


ELIXIR WELLNESS CENTER


8665 NOSE HILL Dr NW, CALGARYy, AB T3G 5T3

CLIENT: ALBERTA HEALTH SERVICES

PROJECT LOCATION

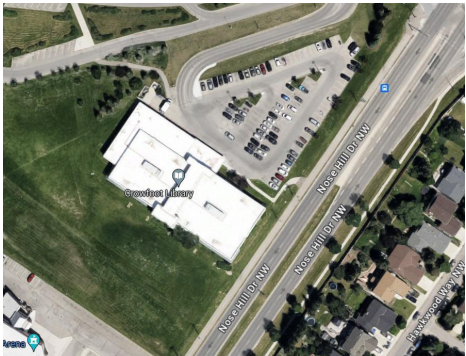

SITE MAP

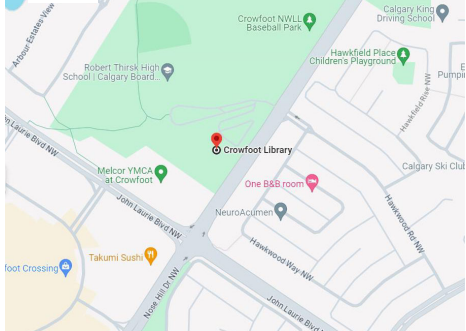

PROJECT BUILDING



LIST OF DRAWINGS

- A4.1 ROP FOCUS AREA 1 CAFE
- A4.2 POWER AND COMMUNICATION FOCUS AREA 1 CAFE
- A5.1 ROP FOCUS AREA 2 GYM
- A5.2 POWER AND COMMUNICATION FOCUS AREA 2 GYM
- A6.1 ROP FOCUS AREA 3 HEALING GARDEN
- A6.2 POWER AND COMMUNICATION FOCUS AREA 3 HEALING GARDEN

PROJECT DESCRIPTION

THIS PROJECT IS ONE STOREY HIGH BUILDING

LEGAL DESCRIPTION

PORTION OF LOT MSR BLK 21

MUNICIPAL ADDRESS:
8665 NOSE HILL DRIVE N.W

ROOM NAME

101

View Name
1/8" = 1'-0"

101

11

ANSI

101

101

101

101

101

101

101

101

ROOM NAME

VIEW NAME

DOOR TAG

WALL TAG

SECTION MARKER

FURNITURE SYMBOL

PHONE AND DATA SYMBOL

QUAD OUTLET SYMBOL

EXIT SIGN SYMBOL

LEVEL MARKER

EMERGENCY EXIT LIGHT SYMBOL

SYMBOL LEGEND

1 : 20

ABBREVIATIONS:

U/S UNDERSIDE
T/O TOP OFF
SIM. SIMILAR
OBC ONTARIO BUILDING CODE
ALUM ALUMINIUM
A.F.F ABOVE FINISH FLOOR
CMU C CONCRETE MASONARY UNIT
& AND
@ AT
FRR FIRE RESISTANCE RATING
MIN MINUTE
FD FLOOR DRAIN




GLAZING LEGEND

SP SPANDERL PANEL WITH INSULATED
CL CLEAR GLASS
TG TEMPERED GLASS

OBC MATRIC

Item	Ontario Building Code Data Matrix Parts 3 & 9	OBC Reference
1	Project Description: ☐ New ☐ Part 11 ☒ Part 3 ☐ Part 9 ☐ Addition ☐ Alteration ☒ Change of Use	2.1.1 9.10.1.3
2	Major Occupancy(s) Group C, Group D	3.1.2.1(1) 9.10.2
3	Building Area (m²) Existing 2,322 sq.m New N/A Total 2,322 sq.m	1.1.3.2 1.1.3.2
4	Gross Area Existing 7,432 sq.m New N/A Total 7,432 sq.m	1.1.3.2 1.1.3.2
5	Number of Storeys Above grade 2 Below grade 0	3.2.1.1 & 1.1.3.2 2.1.1.3
6	Height of Building (m) 4.87 m	2.1.1.3
7	Number of Streets/Access Routes Faces two streets	3.2.2.10 & 3.2.5.5
8	Building Classification Group C, Group D building	3.2.2.20-83 9.10.4
9	Sprinkler System Proposed ☒ entire building ☐ basement only ☐ in lieu of roof rating ☐ not required	3.2.2.20-83 3.2.1.5 3.2.2.17 9.10.8
10	Standpipe required ☐ Yes ☒ No	3.2.9 9.10.7.2
11	Fire Alarm required ☒ Yes ☐ No	3.2.4
12	Water Service/Supply is Adequate ☒ Yes ☐ No	3.2.6
13	High Building ☐ Yes ☒ No	3.2.2.20-83 9.10.6
14	Permitted Construction ☒ Combustible ☐ Non-combustible Actual Construction ☒ Combustible ☐ Non-combustible	3.2.2.20-83 9.10.6
15	Mezzanine(s) Area m² N/A	3.2.1.1 (3) (8) 9.10.4.1
16	Occupant load based on ☐ m²/person ☒ design of building Group C Occupancy 4.65 Load 2,308 persons Group D Occupancy 4.65 Load 3,125 persons	3.1.17.1 9.10.1.3
17	Barrier-free Design ☒ Yes ☐ No (Explain)	3.8 9.5.2
18	Hazardous Substances ☐ Yes ☒ No	3.3.1.2(1) & 3.3.1.19(1) 9.10.1.3
19	Required Fire Resistance Rating (FRR) ☒ FRR (Hours) Horizontal Assemblies Floors 2 Hours Roof 4.5 Mins Mezzanine N/A Hours FRR of Supporting Members Floors 2 Hours Roof 4.5 Mins Mezzanine N/A Hours	Listed Design No. or Description (SG-2) 3.2.2.20-83 & 3.2.1.4 9.10.8 9.10.9
20	Spatial Separation - Construction of Exterior Walls Wall Area of EBP (m²) L.D. (m) L/H or H/L Permitted Max. % of Openings Proposed % of Openings FRR (Hours) Listed Design or Description Comb. Constr. Comb. Constr. Non-comb. Constr.	3.2.3 9.10.14
21	Other - Describe	



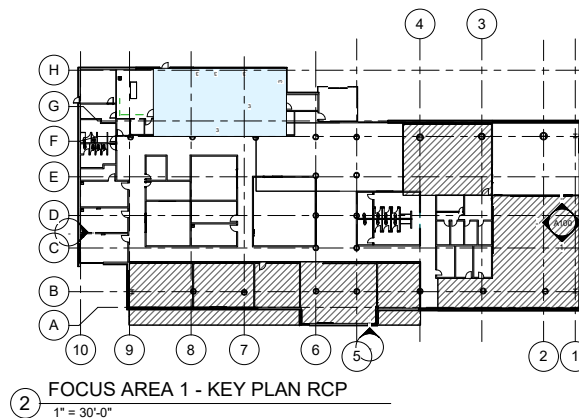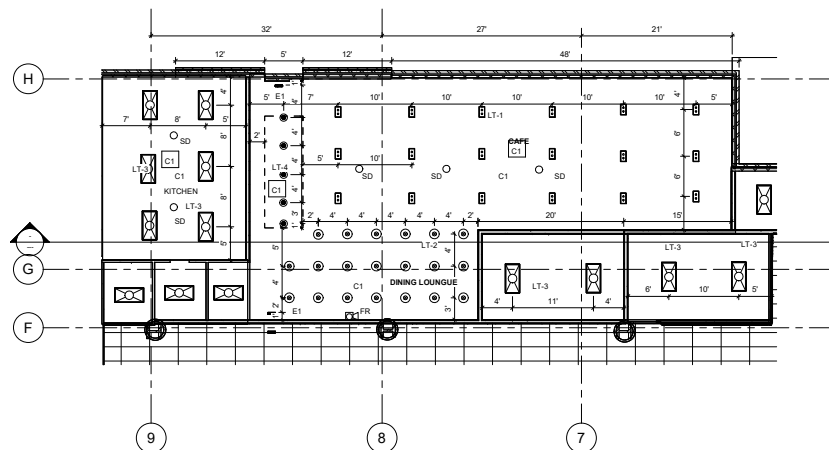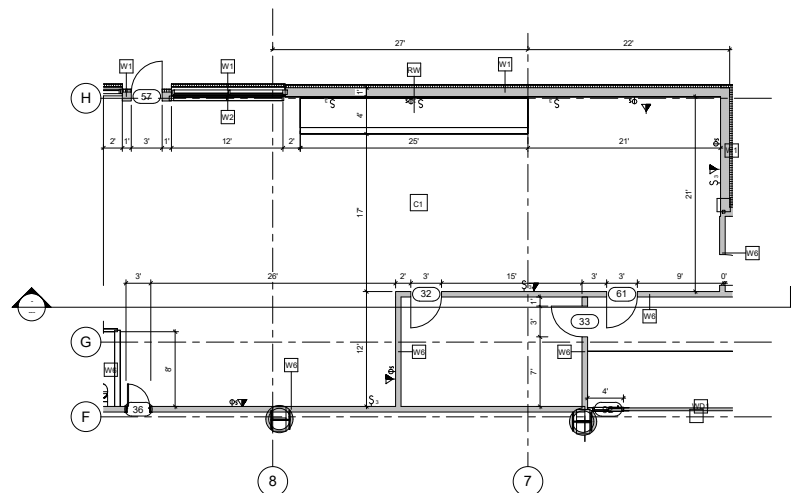

RCP LEGEND		
LIGHT	CODE	DESCRIPTION
	LT-1	2 LED RECESSED LIGHTS
	LT-2	CEILING MOUNTED LED LIGHT
	LT-3	2X4 TROFFER LIGHT
	LT-4	CRYSTAL BALL PENDANT LIGHT
	ES-1	CEILING MOUNT EXIT SIGN
	FRL	FIRE ALARM
	SD	SMOKE DETECTOR

CEILING FINISHE LEGEND		
SYMBOL	CODE	DESCRIPTION
	C1	WATERBORNE CEILING PAINT ULTRA FLAT (508) ASH WHITE
---		SOFT, CEILING LEVEL CHANGES



YORKVILLE
UNIVERSITY

BACHELOR OF INTERIOR DESIGN

NOTES:

NOTES:
THIS PROJECT IS NOT TO BE SCALED

ALL WORK SHALL CONFORM TO THE REQUIREMENTS OF APPLICABLE FEDERAL, STATE, AND LOCAL CODES AND OTHER REQUIREMENTS WHICH HAVE BEEN ADOPTED BY THE LOCAL JURISDICTION OR ARE OTHERWISE APPLICABLE TO THIS PROJECT.

IT SHALL BE THE GENERAL CONTRACTORS RESPONSIBILITY
FOR THE SUPERVISION OF THE WORK.

WRITTEN DIMENSIONS SHALL HAVE PRECEDENCE OVER
SCALED DIMENSIONS. ANY AND ALL
DISCREPANCIES SHALL BE REPORTED TO THE ARCHITECT
IMMEDIATELY, PRIOR TO COMMENCEMENT
OF WORK

ANY PROPOSED SHUT DOWN OF UTILITIES SHALL BE REGISTERED IN WRITING AT LEAST SEVEN (7) WORKING DAYS IN ADVANCE. REQUESTS SHALL BE DIRECTED TO THE ARCHITECT.

ANY PROPOSED WORK THAT TAKES PLACE AFTER NORMAL BUSINESS HOURS SHALL BE MADE IN WRITING AT LEAST SEVEN (7) WORKING DAYS IN ADVANCE. REQUESTS SHALL BE DIRECTED TO THE ARCHITECT.

[illegible]

NORTH



Project Name
ELIXIR WELLNESS CENTER

LOCATION:

8665 Nose Hill Dr NW, Calgary, AB T3G 5T3

DRAWING NAME

FOCUSED AREA 1 RCP CAFE

DATE: 03-09-2024


CHECKED BY BAN ABDULRIDAH

DRAWN BY QURATULAIN FURQAN

SCALE (@ A1)


DRAWING NUMBER A4 1

REV

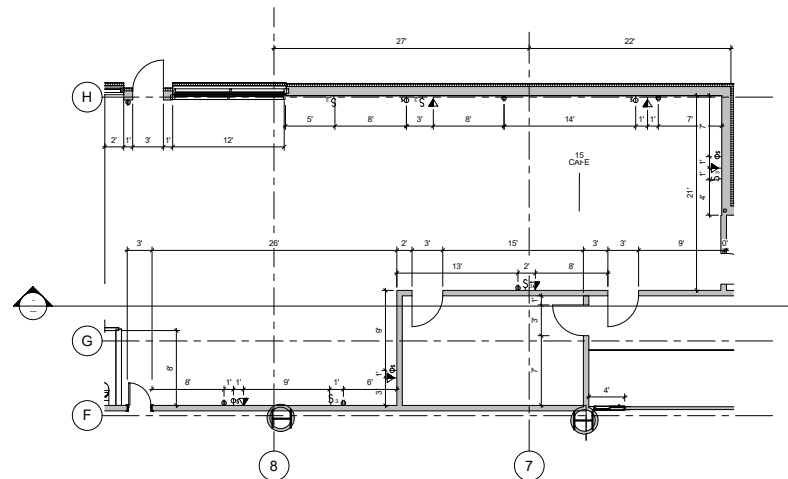

1 FOCUS AREA 1 - POWER AND COMMUNICATION
1 : 75

POWER AND DATA LEGEND	
SYMBOL	DESCRIPTION
	THREE WAY SWITCH
	WALL MOUNTED PHONE AND DATA OUTLET
	WALL MOUNTED SINGLE AND SWITCH
	WALL MOUNTED DUPLEX OUTLET

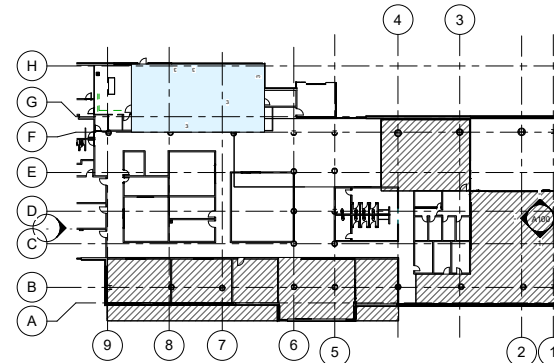

2 FOCUS AREA 1 - KEY PLAN Copy 1
1" = 30'-0"

POWER AND COMMUNICATION PLAN NOTES

- ALL POWER OUTLETS TO BE INSTALLED AS INDICATED ON THE PLAN. VERIFY LOCATIONS AND HEIGHTS WITH THE ARCHITECTURAL DRAWINGS.
 - PROVIDE USB CHARGING OUTLETS IN COMMON AREAS LIKE THE CAFÉ, RECEPTION, AND COMMUNITY GATHERING SPACES FOR USER CONVENIENCE.
- LIGHTING AND SWITCHING:
- SWITCHES SHOULD BE INSTALLED AS PER THE PLAN AND COORDINATED WITH THE LIGHTING LAYOUT AND RCP. ENSURE ALL SWITCHES ARE LABELED AND LOCATED AT ADA-COMPLIANT HEIGHTS.
 - DIMMING CONTROLS ARE TO BE PROVIDED IN FLEXIBLE SPACES LIKE COUNSELING ROOMS AND THE GYM TO ADJUST LIGHTING LEVELS ACCORDING TO USAGE.
 - EMERGENCY LIGHTING AND EXIT SIGNS MUST BE CONNECTED TO AN EMERGENCY POWER SOURCE AND LOCATED PER CODE REQUIREMENTS.
- DEDICATED CIRCUITS:
- PROVIDE DEDICATED CIRCUITS FOR SPECIALIZED EQUIPMENT, SUCH AS GYM MACHINERY, KITCHEN APPLIANCES IN THE CAFÉ, AND MEDICAL EQUIPMENT IN THE WELLNESS CENTER AND CLINIC.
 - ENSURE DEDICATED CIRCUITS ARE AVAILABLE FOR IT AND AV EQUIPMENT IN MEETING ROOMS, CLASSROOMS, AND PRESENTATION AREAS.
 - DATA OUTLETS (RJ45) ARE TO BE PROVIDED IN ALL OFFICES, MEETING ROOMS, RECEPTION AREAS, AND COMMUNITY GATHERING SPACES. COORDINATE WITH THE FURNITURE PLAN FOR EXACT LOCATIONS.
 - ENSURE ADEQUATE WI-FI COVERAGE THROUGHOUT THE FACILITY, PARTICULARLY IN HIGH-TRAFFIC AREAS LIKE THE GYM, CAFÉ, AND HEALING GARDEN.
 - PROVIDE DATA AND COMMUNICATION OUTLETS FOR SECURITY CAMERAS, ACCESS CONTROL PANELS, AND INTERCOM SYSTEMS AS INDICATED ON THE PLAN.
- FIRE ALARM AND LIFE SAFETY SYSTEMS:
- INSTALL FIRE ALARM CONTROL PANELS, SMOKE DETECTORS, AND ANNUNCIATOR PANELS PER THE PLAN AND IN COMPLIANCE WITH LOCAL FIRE CODE REQUIREMENTS.
 - FIRE ALARM DEVICES MUST BE COORDINATED WITH CEILING LAYOUTS AND HVAC SYSTEMS TO ENSURE PROPER COVERAGE AND VISIBILITY.
- COORDINATE ALL POWER AND COMMUNICATION INSTALLATIONS WITH OTHER TRADES, INCLUDING MECHANICAL, PLUMBING, AND ARCHITECTURAL ELEMENTS, TO AVOID CONFLICTS.
 - ENSURE ALL PENETRATIONS FOR ELECTRICAL AND DATA CABLING THROUGH FIRE-RATED ASSEMBLIES ARE SEALED AND COMPLY WITH FIRE SAFETY CODES.
- COMPLIANCE AND SAFETY:
- ALL ELECTRICAL AND COMMUNICATION INSTALLATIONS MUST COMPLY WITH THE NATIONAL ELECTRICAL CODE (NEC), CANADIAN ELECTRICAL CODE (CEC), AND LOCAL BUILDING CODES.
 - PROVIDE ARC FAULT CIRCUIT INTERRUPTERS (AFCI) IN REQUIRED LOCATIONS AS PER CODE.
 - INSTALL SURGE PROTECTION DEVICES FOR SENSITIVE EQUIPMENT AND SYSTEMS.



BACHELOR OF INTERIOR DESIGN

NOTES:

THIS PROJECT IS NOT TO BE SCALED

ALL WORK SHALL CONFORM TO THE REQUIREMENTS OF APPLICABLE FEDERAL, STATE, AND LOCAL CODES AND OTHER REQUIREMENTS WHICH HAVE BEEN ADOPTED BY THE LOCAL JURISDICTION OR ARE OTHERWISE APPLICABLE TO THIS PROJECT.

IT SHALL BE THE GENERAL CONTRACTORS RESPONSIBILITY FOR THE SUPERVISION OF THE WORK.

WRITTEN DIMENSIONS SHALL HAVE PRECEDENCE OVER SCALED DIMENSIONS. ANY AND ALL DISCREPANCIES SHALL BE REPORTED TO THE ARCHITECT IMMEDIATELY, PRIOR TO COMMENCEMENT OF WORK.

ANY PROPOSED SHUT DOWN OF UTILITIES SHALL BE REGISTERED IN WRITING AT LEAST SEVEN (7) WORKING DAYS IN ADVANCE. REQUESTS SHALL BE DIRECTED TO THE ARCHITECT.

ANY PROPOSED WORK THAT TAKES PLACE AFTER NORMAL BUSINESS HOURS SHALL BE MADE IN WRITING AT LEAST SEVEN (7) WORKING DAYS IN ADVANCE. REQUESTS SHALL BE DIRECTED TO THE ARCHITECT.

REV	DESCRIPTION	DATE

NORTH



Project Name ELIXIR WELLNESS CENTER

LOCATION:

8865 Nose Hill Dr NW, Calgary, AB T3G 5T3

DRAWING NAME

FOCUSED AREA 1 CAFE POWER AND COMMUNICATION PLAN

DATE:

03-09-2024

CHECKED BY

BAN ABDULRIDAH

DRAWN BY

QURATULAIN FURQAN

SCALE (@ A1)


DRAWING NUMBER

A4.2


REV

N/A


2024-09-03 11:43:15 PM

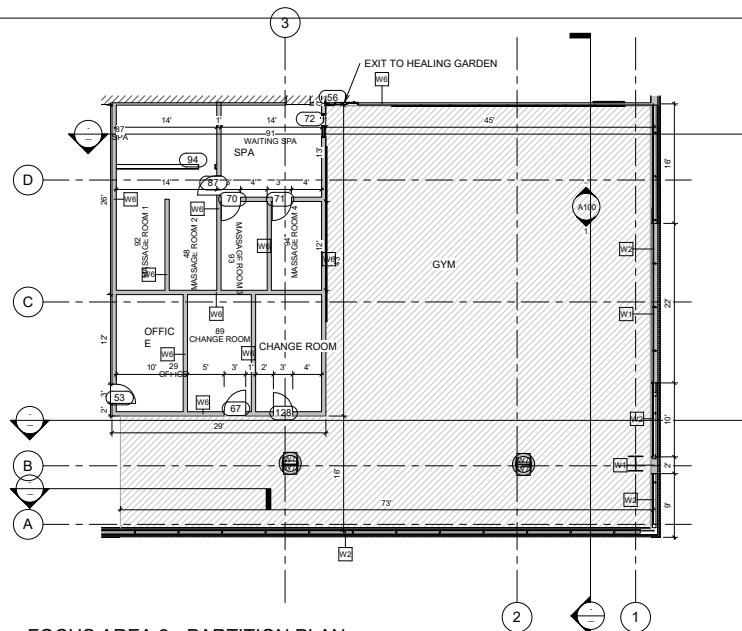

3 FOCUS AREA 2 - PARTITION PLAN
1/8" = 1'-0"

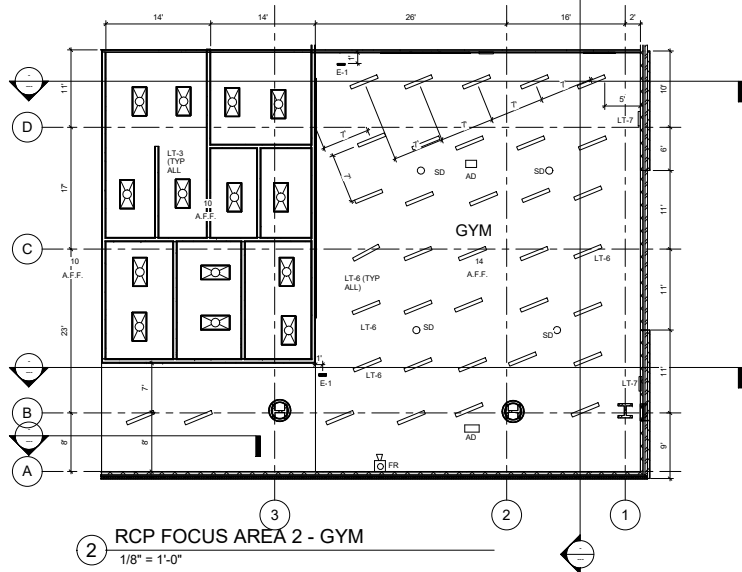

2 RCP FOCUS AREA 2 - GYM
1/8" = 1'-0"

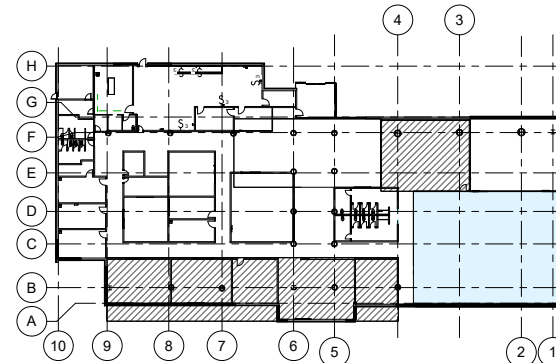

1 FOCUS AREA 2 - KEY PLAN 2 Copy 1
1" = 30'-0"

RCP LEGEND GYM		
SYMBOL	CODE	DESCRIPTION
	LT-6	SUSPENDED LINEAR LIGHT CABLE MOUNT
	LT-4	2x4 TROFFER LIGHT
	LT-7	WALL MOUNT COOPER LED LIGHT
	E-1	CEILING MOUNT EXIT SIGN
	FR	FIRE ALARM
	SD	SMOKE DETECTOR
	AD	CEILING MOUNT SOUND SYSTEM

RCP FINISHES LEGEND	
SYMBOL	DESCRIPTION
	WATERBORNE CEILING PAINT - ULTRA FLAT
	BENJAMIN MOORE WHITE



BACHELOR OF INTERIOR DESIGN

NOTES:

THIS PROJECT IS NOT TO BE SCALED

ALL WORK SHALL CONFORM TO THE REQUIREMENTS OF APPLICABLE FEDERAL, STATE, AND LOCAL CODES AND OTHER REQUIREMENTS WHICH HAVE BEEN ADOPTED BY THE LOCAL JURISDICTION OR ARE OTHERWISE APPLICABLE TO THIS PROJECT.

IT SHALL BE THE GENERAL CONTRACTORS RESPONSIBILITY FOR THE SUPERVISION OF THE WORK.

WRITTEN DIMENSIONS SHALL HAVE PRECEDENCE OVER SCALED DIMENSIONS. ANY AND ALL DISCREPANCIES SHALL BE REPORTED TO THE ARCHITECT IMMEDIATELY, PRIOR TO COMMENCEMENT OF WORK.

ANY PROPOSED SHUT DOWN OF UTILITIES SHALL BE REGISTERED IN WRITING AT LEAST SEVEN (7) WORKING DAYS IN ADVANCE. REQUESTS SHALL BE DIRECTED TO THE ARCHITECT.

ANY PROPOSED WORK THAT TAKES PLACE AFTER NORMAL BUSINESS HOURS SHALL BE MADE IN WRITING AT LEAST SEVEN (7) WORKING DAYS IN ADVANCE. REQUESTS SHALL BE DIRECTED TO THE ARCHITECT.

REV	DESCRIPTION	DATE

NORTH



Project Name ELIXIR WELLNESS CENTER

LOCATION:

8965 Nose Hill Dr NW, Calgary, AB T3G 5T3

DRAWING NAME

FOCUS AREA 2 GYM RCP

DATE: 03-09-2024

CHECKED BY BAN ABDULRIDAH


DRAWN BY QURATULAIN FURQAN

SCALE (@ A1)

DRAWING NUMBER A5.1

REV
NA


2024/09/04 9:57:17 AM

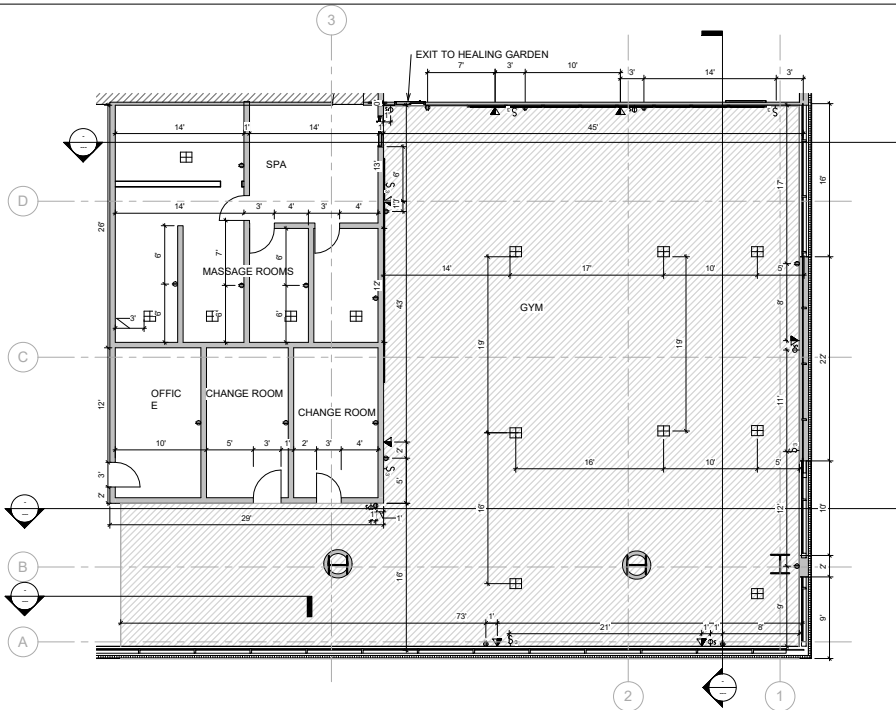

2 FOCUS AREA 2 - POWER AND COMMUNICATION PLAN
1:75

POWER AND DATA LEGEND	
SYMBOL	DESCRIPTION
	THREE WAY SWITCH
	WALL MOUNTED PHONE AND DATA OUTLET
	WALL MOUNTED SINGLE AND SWITCH
	WALL MOUNTED DUPLEX OUTLET
	FLOOR QUAD OUTLET FOR GYM EQUIPMENT

POWER AND COMMUNICATION LEGEND GYM
3/16" = 1'-0"

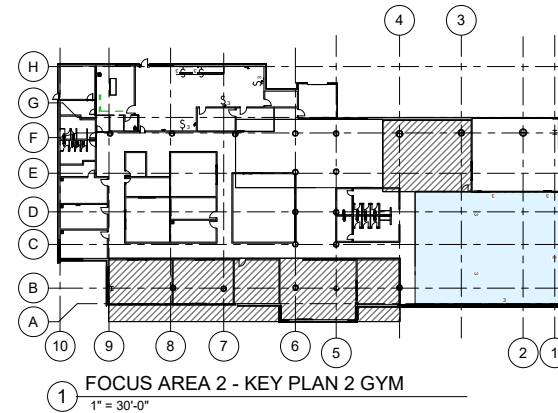

1 FOCUS AREA 2 - KEY PLAN 2 GYM
1" = 30'-0"

GENERAL NOTES

CODE COMPLIANCE:

- ALL ELECTRICAL AND COMMUNICATION WORK MUST COMPLY WITH THE LATEST EDITION OF THE CANADIAN ELECTRICAL CODE (CEC), LOCAL ELECTRICAL CODES, AND ALL OTHER RELEVANT CODES AND STANDARDS.

COORDINATION:

- COORDINATE THE LOCATION OF ALL ELECTRICAL OUTLETS, SWITCHES, LIGHTING, AND COMMUNICATION DEVICES WITH ARCHITECTURAL, MECHANICAL AND STRUCTURAL PLANS TO AVOID CONFLICTS.
- CONFIRM THE FINAL PLACEMENT OF ALL POWER AND COMMUNICATION OUTLETS WITH THE PROJECT MANAGER OR ARCHITECT ON-SITE PRIOR TO INSTALLATION.

ELECTRICAL INSTALLATIONS:

- ALL ELECTRICAL OUTLETS IN THE GYM AREA SHALL BE GROUNDED AND INSTALLED PER CODE. OUTLETS IN WET OR DAMP LOCATIONS MUST BE GROUND-FULT CIRCUIT INTERRUPTER (GFCI) PROTECTED.
- PROVIDE DEDICATED CIRCUITS FOR GYM EQUIPMENT AS REQUIRED. ENSURE CIRCUITS HAVE APPROPRIATE AMPERAGE RATINGS BASED ON THE EQUIPMENT SPECIFICATIONS.
- INSTALL POWER OUTLETS AT LOCATIONS DESIGNATED ON THE DRAWINGS, ENSURING THEY ARE ACCESSIBLE AND NOT OBSTRUCTED BY GYM EQUIPMENT OR FURNISHINGS.
- ALL WIRING TO BE CONCEALED IN WALLS OR CEILINGS UNLESS OTHERWISE NOTED.

COMMUNICATION SYSTEMS:

- INSTALL DATA AND COMMUNICATION OUTLETS (E.G., ETHERNET PORTS, AV CONNECTIONS) AT THE LOCATIONS SHOWN ON THE PLANS. ALL OUTLETS SHALL BE CAT 6 MINIMUM FOR HIGH-SPEED DATA TRANSMISSION.
- PROVIDE CABLE MANAGEMENT SOLUTIONS TO ENSURE A NEAT AND SAFE INSTALLATION, ESPECIALLY NEAR GYM EQUIPMENT.
- COORDINATE WITH THE IT TEAM FOR PROPER TERMINATION, LABELING, AND TESTING OF ALL COMMUNICATION LINES.

EMERGENCY POWER AND SIGNAGE:

- EMERGENCY POWER CIRCUITS MUST BE INSTALLED FOR LIFE SAFETY SYSTEMS, INCLUDING EXIT SIGNS AND EMERGENCY LIGHTING, AS PER LOCAL CODE REQUIREMENTS.
- PROVIDE ADEQUATE SIGNAGE FOR ALL POWER AND COMMUNICATION PANELS AND OUTLETS, INDICATING THE CIRCUIT NUMBER AND PURPOSE.

EQUIPMENT COORDINATION:

- COORDINATE THE POWER REQUIREMENTS FOR ALL GYM EQUIPMENT (E.G., TREADMILLS, ELLIPTICALS, TVS) WITH THE MANUFACTURER'S SPECIFICATIONS. INSTALL APPROPRIATE RECEPTACLES AND BREAKERS AS NEEDED.
- PROVIDE POWER OUTLETS FOR WALL-MOUNTED OR CEILING-MOUNTED TVS AND AV SYSTEMS AS PER THE AV PLAN.

TESTING AND COMMISSIONING:

- ALL PANELS, CIRCUITS, OUTLETS, AND COMMUNICATION PORTS MUST BE CLEARLY LABELED FOR EASY IDENTIFICATION AND MAINTENANCE.

SUBMITTALS AND APPROVALS:

- SUBMIT SHOP DRAWINGS, EQUIPMENT SPECIFICATIONS, AND SAMPLES FOR ALL POWER AND COMMUNICATION DEVICES FOR APPROVAL BEFORE PROCUREMENT AND INSTALLATION.



BACHELOR OF INTERIOR DESIGN

NOTES:

THIS PROJECT IS NOT TO BE SCALED

ALL WORK SHALL CONFORM TO THE REQUIREMENTS OF APPLICABLE FEDERAL, STATE, AND LOCAL CODES AND OTHER REQUIREMENTS WHICH HAVE BEEN ADOPTED BY THE LOCAL JURISDICTION OR ARE OTHERWISE APPLICABLE TO THIS PROJECT.

IT SHALL BE THE GENERAL CONTRACTORS RESPONSIBILITY FOR THE SUPERVISION OF THE WORK.

WRITTEN DIMENSIONS SHALL HAVE PRECEDENCE OVER SCALED DIMENSIONS. ANY AND ALL DISCREPANCIES SHALL BE REPORTED TO THE ARCHITECT IMMEDIATELY, PRIOR TO COMMENCEMENT OF WORK.

ANY PROPOSED SHUT DOWN OF UTILITIES SHALL BE REGISTERED IN WRITING AT LEAST SEVEN (7) WORKING DAYS IN ADVANCE. REQUESTS SHALL BE DIRECTED TO THE ARCHITECT.

ANY PROPOSED WORK THAT TAKES PLACE AFTER NORMAL BUSINESS HOURS SHALL BE MADE IN WRITING AT LEAST SEVEN (7) WORKING DAYS IN ADVANCE. REQUESTS SHALL BE DIRECTED TO THE ARCHITECT.

REV	DESCRIPTION	DATE

NORTH



Project Name ELIXIR WELLNESS CENTER

LOCATION:

8665 Nose Hill Dr NW, Calgary, AB T3G 5T3

DRAWING NAME

FOCUS AREA 2 GYM POWER AND COMMUNICATION

DATE:

03-09-2024

CHECKED BY

BAN ABDULRIDAH

DRAWN BY


QURATULAIN FURQAN

SCALE (@ A1)

DRAWING NUMBER A5.2

REV


NA

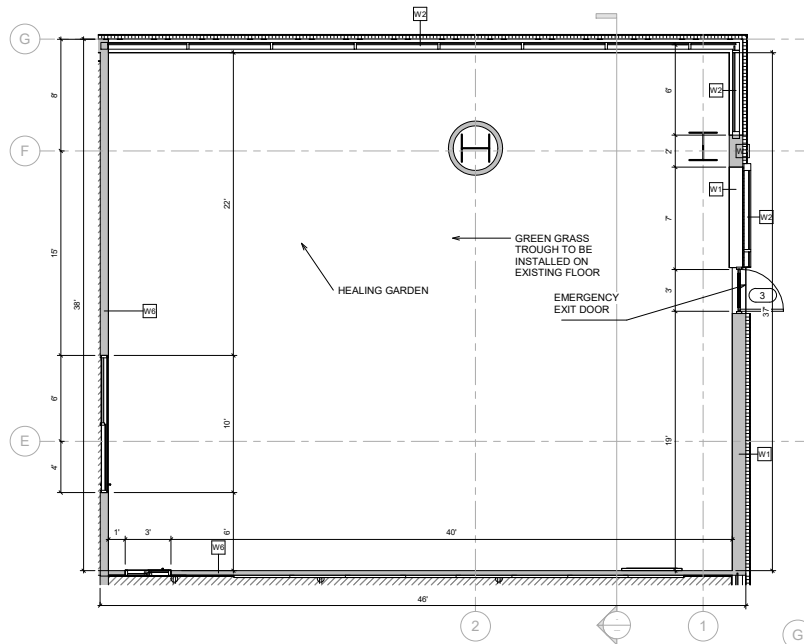


2 FOCUS AREA 3 - PARTITION PLAN
1 : 50

RCP LEGEND GYM		
SYMBOL	CODE	DESCRIPTION
	LT-4	SUSPENDED LINEAR LIGHT CABLE MOUNT
	LT-7	WALL MOUNT COOPER LED LIGHT
	E-1	CEILING MOUNT EXIT SIGN
	FR	FIRE ALARM
	SD	SMOKE DETECTOR

RCP FINISHES LEGEND	
SYMBOL	DESCRIPTION
	WATERBORNE CEILING PAINT - ULTRA FLAT
	SOLIGNUM MOORE WHITE

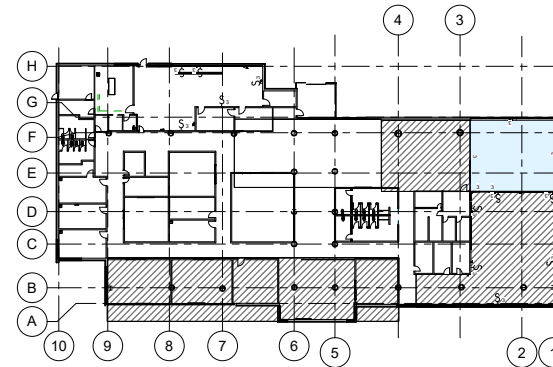

1 FOCUS AREA 3 - KEY PLAN 3 Copy 1
1" = 30'-0"

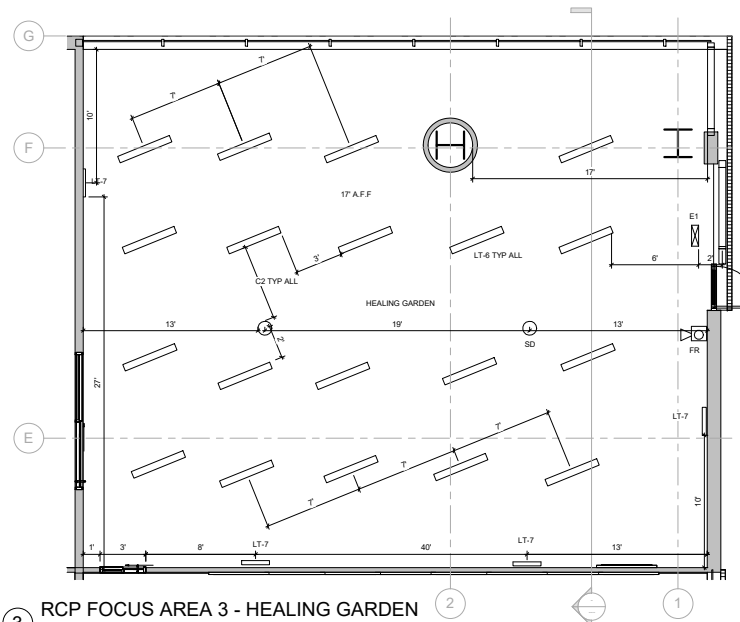

3 RCP FOCUS AREA 3 - HEALING GARDEN
1 : 50



BACHELOR OF INTERIOR DESIGN

NOTES:

THIS PROJECT IS NOT TO BE SCALED

ALL WORK SHALL CONFORM TO THE REQUIREMENTS OF APPLICABLE FEDERAL, STATE, AND LOCAL CODES AND OTHER REQUIREMENTS WHICH HAVE BEEN ADOPTED BY THE LOCAL JURISDICTION OR ARE OTHERWISE APPLICABLE TO THIS PROJECT.

IT SHALL BE THE GENERAL CONTRACTORS RESPONSIBILITY FOR THE SUPERVISION OF THE WORK.

WRITTEN DIMENSIONS SHALL HAVE PRECEDENCE OVER SCALED DIMENSIONS. ANY AND ALL DISCREPANCIES SHALL BE REPORTED TO THE ARCHITECT IMMEDIATELY PRIOR TO COMMENCEMENT OF WORK.

ANY PROPOSED SHUT DOWN OF UTILITIES SHALL BE REGISTERED IN WRITING AT LEAST SEVEN (7) WORKING DAYS IN ADVANCE. REQUESTS SHALL BE DIRECTED TO THE ARCHITECT.

ANY PROPOSED WORK THAT TAKES PLACE AFTER NORMAL BUSINESS HOURS SHALL BE MADE IN WRITING AT LEAST SEVEN (7) WORKING DAYS IN ADVANCE. REQUESTS SHALL BE DIRECTED TO THE ARCHITECT.

REV	DESCRIPTION	DATE

NORTH



Project Name
ELIXIR WELLNESS CENTER

LOCATION:
8965 Nose Hill Dr NW, Calgary, AB T3G 5T3

DRAWING NAME

FOCUS AREA 3 STUDY LOUNGE

DATE: 03-09-2024

CHECKED BY BAN ABDULRIDAH


DRAWN BY QURATULAIN FURQAN

SCALE (@ A1)

DRAWING NUMBER A6.1

REV N/A


2024/09/04 1:30:21 PM

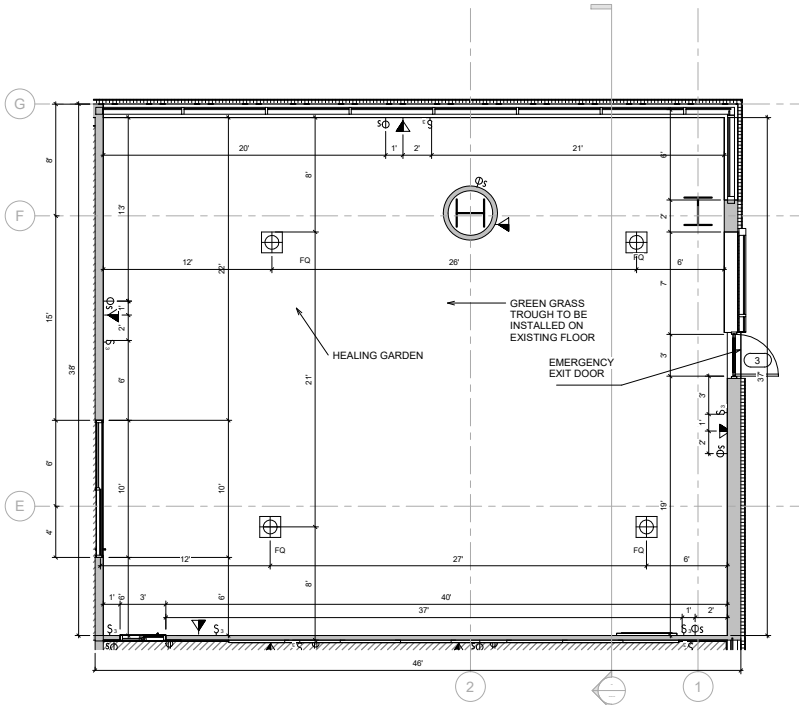

2 FOCUS AREA 3 - POWER AND COMMUNICATION
1 : 50

POWER AND DATA LEGEND	
SYMBOL	DESCRIPTION
	THREE WAY SWITCH
	WALL MOUNTED PHONE AND DATA OUTLET
	WALL MOUNTED SINGLE SWITCH
	WALL MOUNTED DUPLEX OUTLET
	FLOOR QUAD OUTLET

3/16" = 1'-0"
POWER AND COMMUNICATION LEGEND HEALING GARDEN

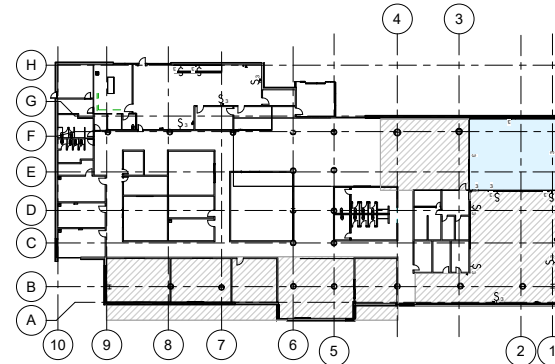

1 FOCUS AREA 3 - KEY PLAN P AND C
1" = 30'-0"

GENERAL NOTES

CODE COMPLIANCE:

- ALL ELECTRICAL AND COMMUNICATION INSTALLATIONS MUST COMPLY WITH THE LATEST EDITION OF THE CANADIAN ELECTRICAL CODE (CEC), LOCAL CODES, AND ANY OTHER RELEVANT STANDARDS OR REGULATIONS.
- INSTALLATIONS IN EXTERIOR OR DAMP LOCATIONS MUST FOLLOW APPROPRIATE STANDARDS FOR OUTDOOR.

COORDINATION AND SITE VERIFICATION:

- COORDINATE ALL POWER AND COMMUNICATION DEVICE LOCATIONS WITH ARCHITECTURAL, LANDSCAPE, AND STRUCTURAL PLANS TO AVOID CONFLICTS.
- VERIFY ON-SITE CONDITIONS AND CONFIRM THE FINAL LOCATION OF ALL POWER AND COMMUNICATION OUTLETS WITH THE PROJECT MANAGER OR LANDSCAPE ARCHITECT PRIOR TO INSTALLATION.

ELECTRICAL INSTALLATIONS:

- ALL ELECTRICAL OUTLETS, FIXTURES, AND JUNCTION BOXES IN OUTDOOR OR DAMP LOCATIONS MUST BE WEATHERPROOF AND RATED FOR OUTDOOR USE.
- GROUND-FAULT CIRCUIT INTERRUPTER (GFCI) PROTECTION IS REQUIRED FOR ALL OUTDOOR RECEPTACLES AND CIRCUITS TO ENSURE SAFETY.
- PROVIDE UNDERGROUND CONDUIT AS NEEDED FOR POWER DISTRIBUTION. ALL UNDERGROUND CONDUITS MUST BE ADEQUATELY PROTECTED, BURIED AT THE SPECIFIED DEPTH PER CODE, AND MARKED WITH WARNING TAPE.
- COORDINATE WITH LANDSCAPE DESIGN TO ENSURE THAT ALL CONDUITS AND POWER LINES DO NOT INTERFERE WITH PLANT ROOTS, IRRIGATION SYSTEMS, OR WATER FEATURES.

LIGHTING AND CONTROLS:

- INSTALL LANDSCAPE AND GARDEN LIGHTING FIXTURES PER THE REFLECTED CEILING PLAN (RCP) AND LIGHTING SCHEDULE. FIXTURES SHOULD BE IP65 OR HIGHER-RATED FOR WATER AND DUST PROTECTION.
- PROVIDE LOW-VOLTAGE LIGHTING FOR PATHWAYS, PLANTING BEDS, AND OTHER GARDEN FEATURES TO CREATE A SOOTHING AMBIANCE. ALL LOW-VOLTAGE TRANSFORMERS SHOULD BE INSTALLED IN A CONCEALED BUT ACCESSIBLE LOCATION.
- ENSURE LIGHTING CONTROLS, SUCH AS DIMMERS, MOTION SENSORS, OR TIMERS, ARE INSTALLED IN ACCESSIBLE LOCATIONS AND ARE WEATHER-RESISTANT. INCLUDE A CENTRAL CONTROL SYSTEM FOR EASE OF OPERATION.

COMMUNICATION SYSTEMS:

- INSTALL DATA AND COMMUNICATION OUTLETS (E.G., ETHERNET PORTS, AUDIO CONNECTIONS) AT THE DESIGNATED POINTS IN THE GARDEN AREA. ENSURE THESE OUTLETS ARE WEATHERPROOF AND SUITABLE FOR OUTDOOR USE.
- INSTALL OUTDOOR-RATED WI-FI ACCESS POINTS IF REQUIRED, ENSURING ADEQUATE COVERAGE THROUGHOUT THE HEALING GARDEN.
- PROVIDE ADEQUATE CABLEING AND CONDUIT PROTECTION TO PREVENT DAMAGE FROM LANDSCAPING ACTIVITIES, WEATHER, AND OTHER ENVIRONMENTAL FACTORS.

POWER SUPPLY FOR SPECIAL FEATURES:

- PROVIDE DEDICATED CIRCUITS FOR ANY SPECIAL GARDEN FEATURES SUCH AS WATER FOUNTAINS, IRRIGATION CONTROL SYSTEMS, OUTDOOR HEATERS, OR SOUND SYSTEMS. ENSURE THESE CIRCUITS ARE ON WEATHERPROOF BREAKERS AND ARE EASILY ACCESSIBLE FOR MAINTENANCE.
- ENSURE ALL EQUIPMENT ENCLOSURES FOR SPECIAL FEATURES ARE LOCKABLE, WATERPROOF, AND VENTED AS NECESSARY.



BACHELOR OF INTERIOR DESIGN

NOTES:

THIS PROJECT IS NOT TO BE SCALED

ALL WORK SHALL CONFORM TO THE REQUIREMENTS OF APPLICABLE FEDERAL, STATE, AND LOCAL CODES AND OTHER REQUIREMENTS WHICH HAVE BEEN ADOPTED BY THE LOCAL JURISDICTION OR ARE OTHERWISE APPLICABLE TO THIS PROJECT.

IT SHALL BE THE GENERAL CONTRACTORS RESPONSIBILITY FOR THE SUPERVISION OF THE WORK.

WRITTEN DIMENSIONS SHALL HAVE PRECEDENCE OVER SCALED DIMENSIONS. ANY AND ALL DISCREPANCIES SHALL BE REPORTED TO THE ARCHITECT IMMEDIATELY PRIOR TO COMMENCEMENT OF WORK.

ANY PROPOSED SHUT DOWN OF UTILITIES SHALL BE REGISTERED IN WRITING AT LEAST SEVEN (7) WORKING DAYS IN ADVANCE. REQUESTS SHALL BE DIRECTED TO THE ARCHITECT.

ANY PROPOSED WORK THAT TAKES PLACE AFTER NORMAL BUSINESS HOURS SHALL BE MADE IN WRITING AT LEAST SEVEN (7) WORKING DAYS IN ADVANCE. REQUESTS SHALL BE DIRECTED TO THE ARCHITECT.

REV	DESCRIPTION	DATE

NORTH



Project Name
ELIXIR WELLNESS CENTER

LOCATION:

8865 Rose Hill Dr NW, Calgary, AB T3G 5T3

DRAWING NAME

FOCUS AREA 3 STUDY LOUNGE

DATE: 03-09-2024

CHECKED BY BAN ABDULRIDAH

DRAWN BY QURATULAIN FURQAN

SCALE (@ A1)

DRAWING NUMBER A6.2

REV N/A

2024/09/04 12:51:33 PM